


11. PROVIDE (2) #8 & (1) #10G IN 1" CORD FROM ELECTRICAL PANEL P-B-9 FOR SECURITY CAMERAS.
12. PROVIDE FLOOD LIGHTS FOR SITE SIGNAGE AND ENERGIZE THROUGH LIGHTING CONTACTOR WITH (2) #6 & (1) #6G IN 1".
13. PROVIDE (2) 1-1/2" C FOR LOW VOLTAGE CABLEING.
14. PROVIDE LIGHT POLE CONCRETE BASE, REFER TO DETAIL 11E-602 FOR ADDITIONAL REQUIREMENTS.
15. PROVIDE FLOOD LIGHTING FOR FLAG POLES. COORDINATE FINAL LIGHTING WITH GC PRIOR TO ROUGH-IN. ENERGIZE THROUGH LIGHTING CONTACTOR WITH (2) #6 & (1) #6G IN 1".
16. PROVIDE (2) #6 & (1) #10G IN 1" C FOR SITE LIGHTING. SITE LIGHTS TO BE CONTROLLED THROUGH ELECTRONIC TIME CLOCK LOCATED IN STORAGE BUILDING.
17. PROVIDE (2) 208V/1PH 40A ELECTRICAL CONNECTIONS TO ELECTRIC EV CHARGERS WITH (2) SETS OF (2) #6, (1) #8M & (1) #10G IN 1". COORDINATE FINAL LIGHTING AND FINAL EV CHARGER SPECIFICATIONS WITH OWNER PRIOR TO ROUGH-IN.
18. PROVIDE 12" W X 18" L X 18" D IN GRADE QUATIZE BOX WITH TIER 8 (2) BOLT COVER, "QUATIZE "PG" STYLE OR APPROVED EQUAL). PROVIDE ENGRAVED LID TO SAY "COMMUNICATION".

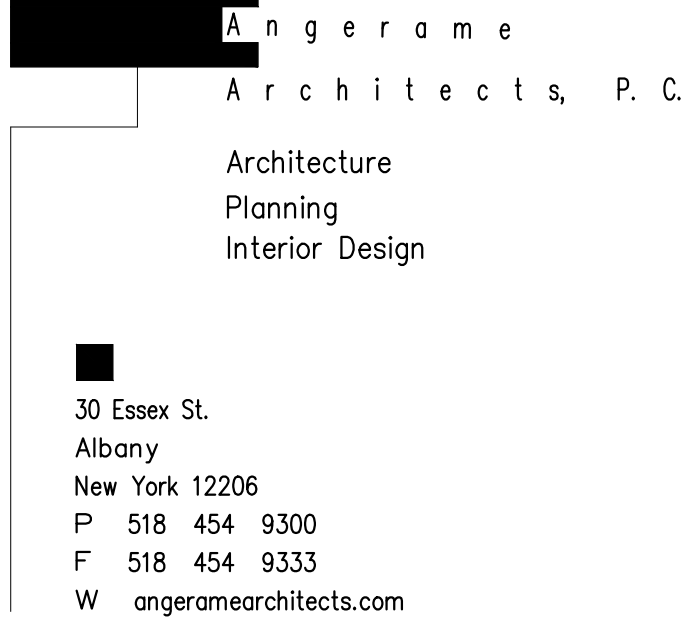

ALBANY COUNTY
SHAKER PLACE &
D.P.W.
NEW VEHICLE STORAGE
FACILITY

Hill House Road
Albany, New York 12211

Civil Engineer:
studioA, Landscape Architecture &
Engineering D.P.C.
38 High Rock Ave, Suite 3
Saratoga Springs, NY 12866
Phone: (518) 832-4005

Structural Engineer:
studioA, Landscape Architecture &
Engineering D.P.C.
38 High Rock Ave, Suite 3
Saratoga Springs, NY 12866
Phone: (518) 832-4005


Mechanical/Plumbing/Electric Engineer:
Engineered Solutions
646 Plank Rd. #104 Clifton Park, NY 12065
Phone: (518) 280-2410

Construction Drawings
NOT FOR CONSTRUCTION

SITE PLAN

Drawing Number

Date: *October 3, 2023*

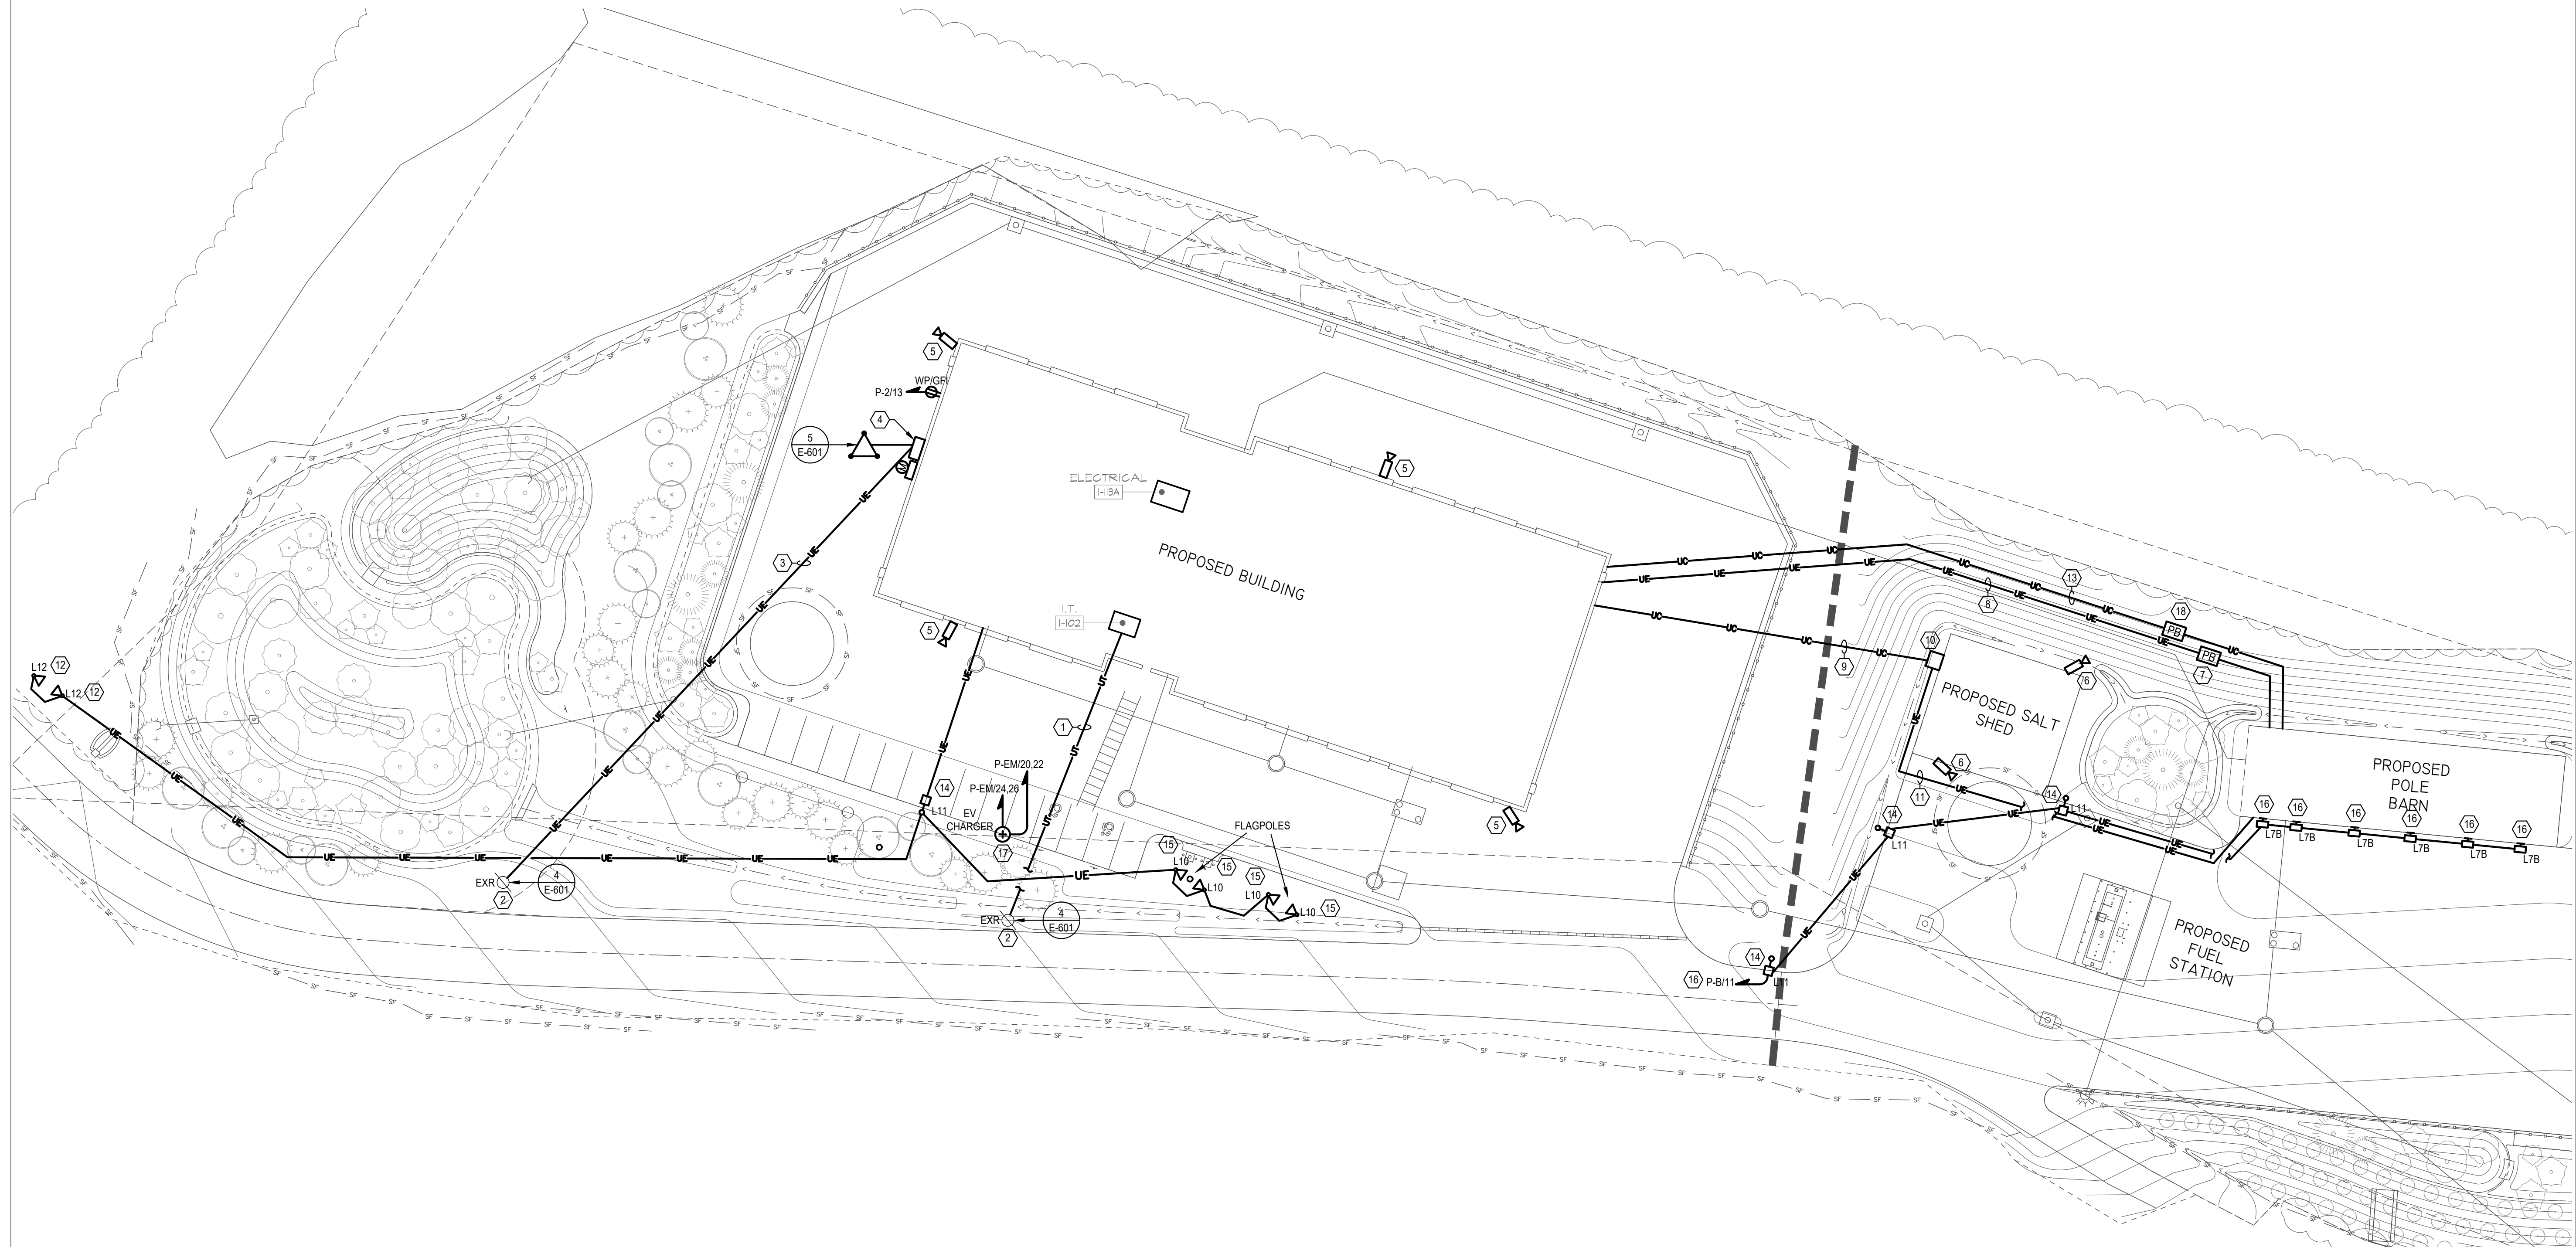

SCALE: 1" = 30' - 0"

1
E-101